





MAIN DECK

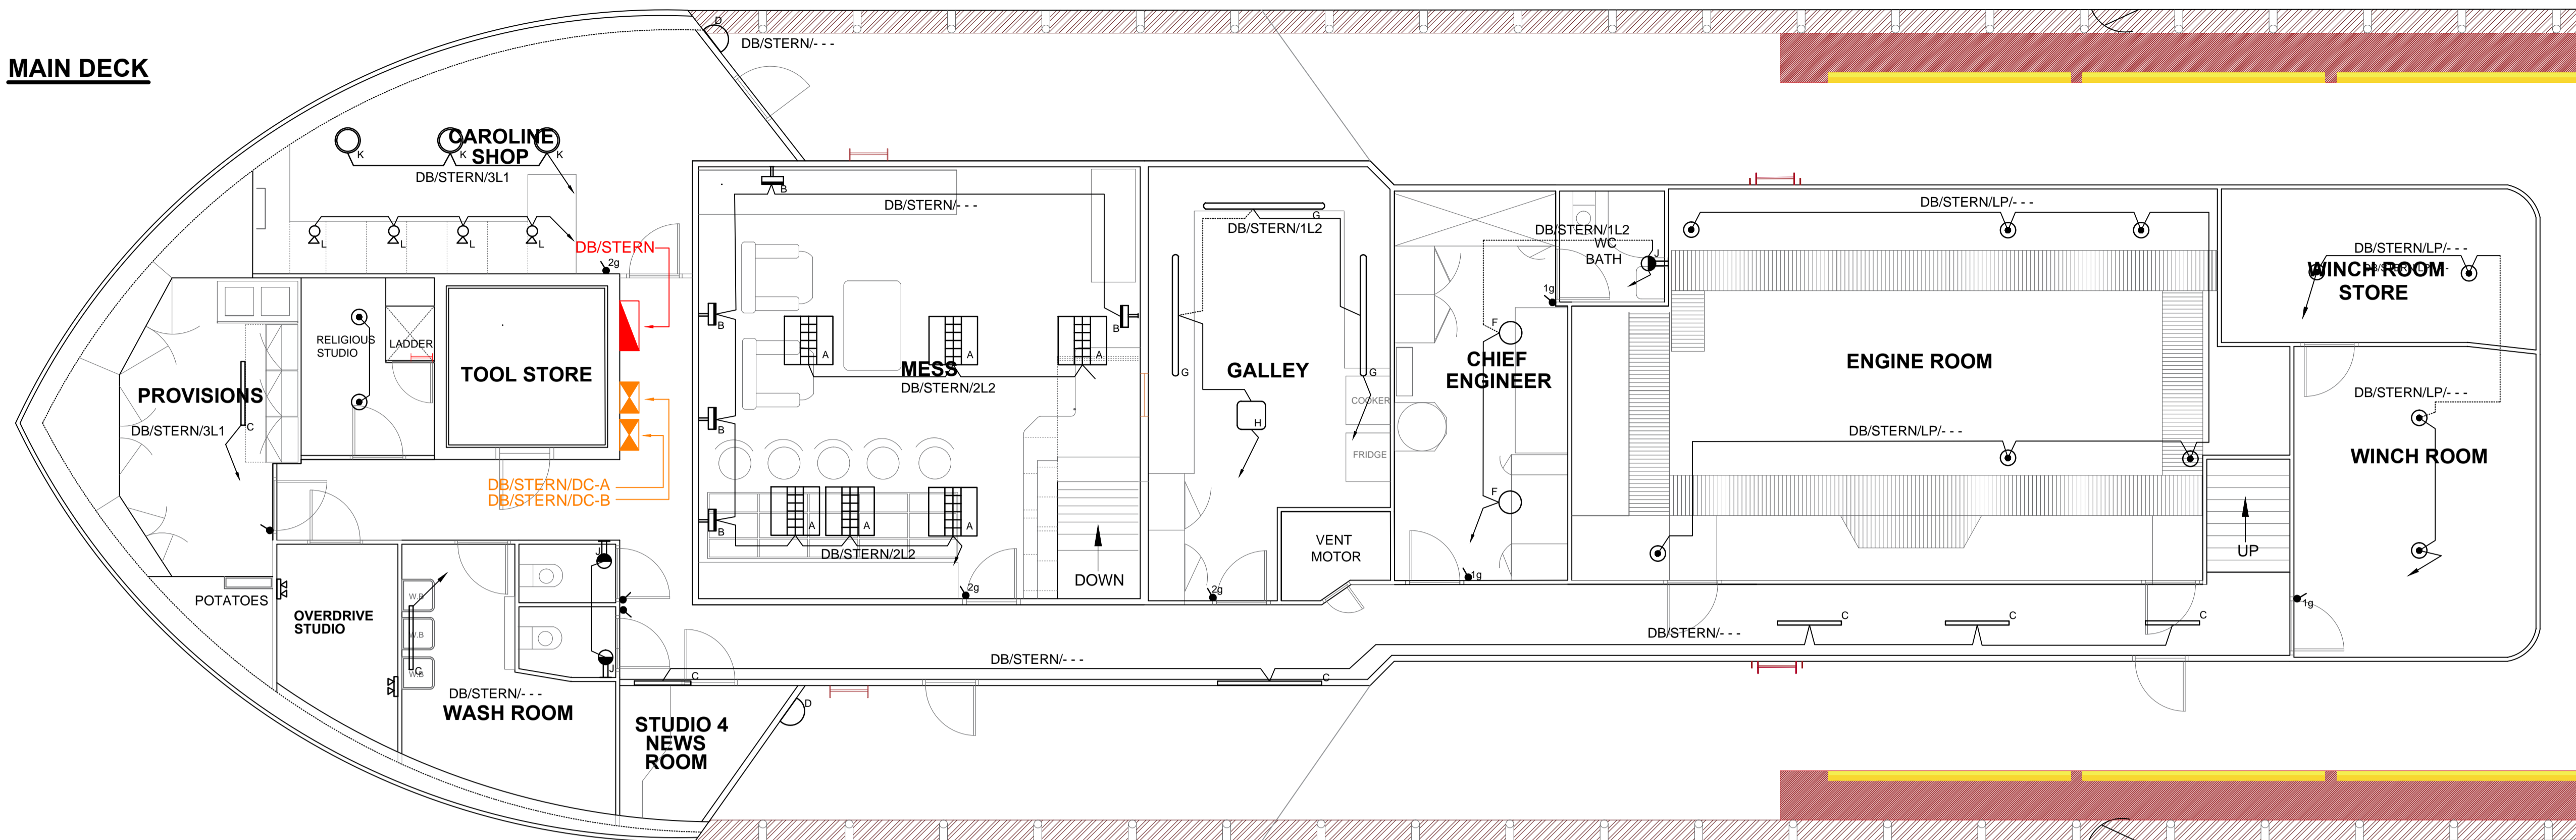

BRIDGE

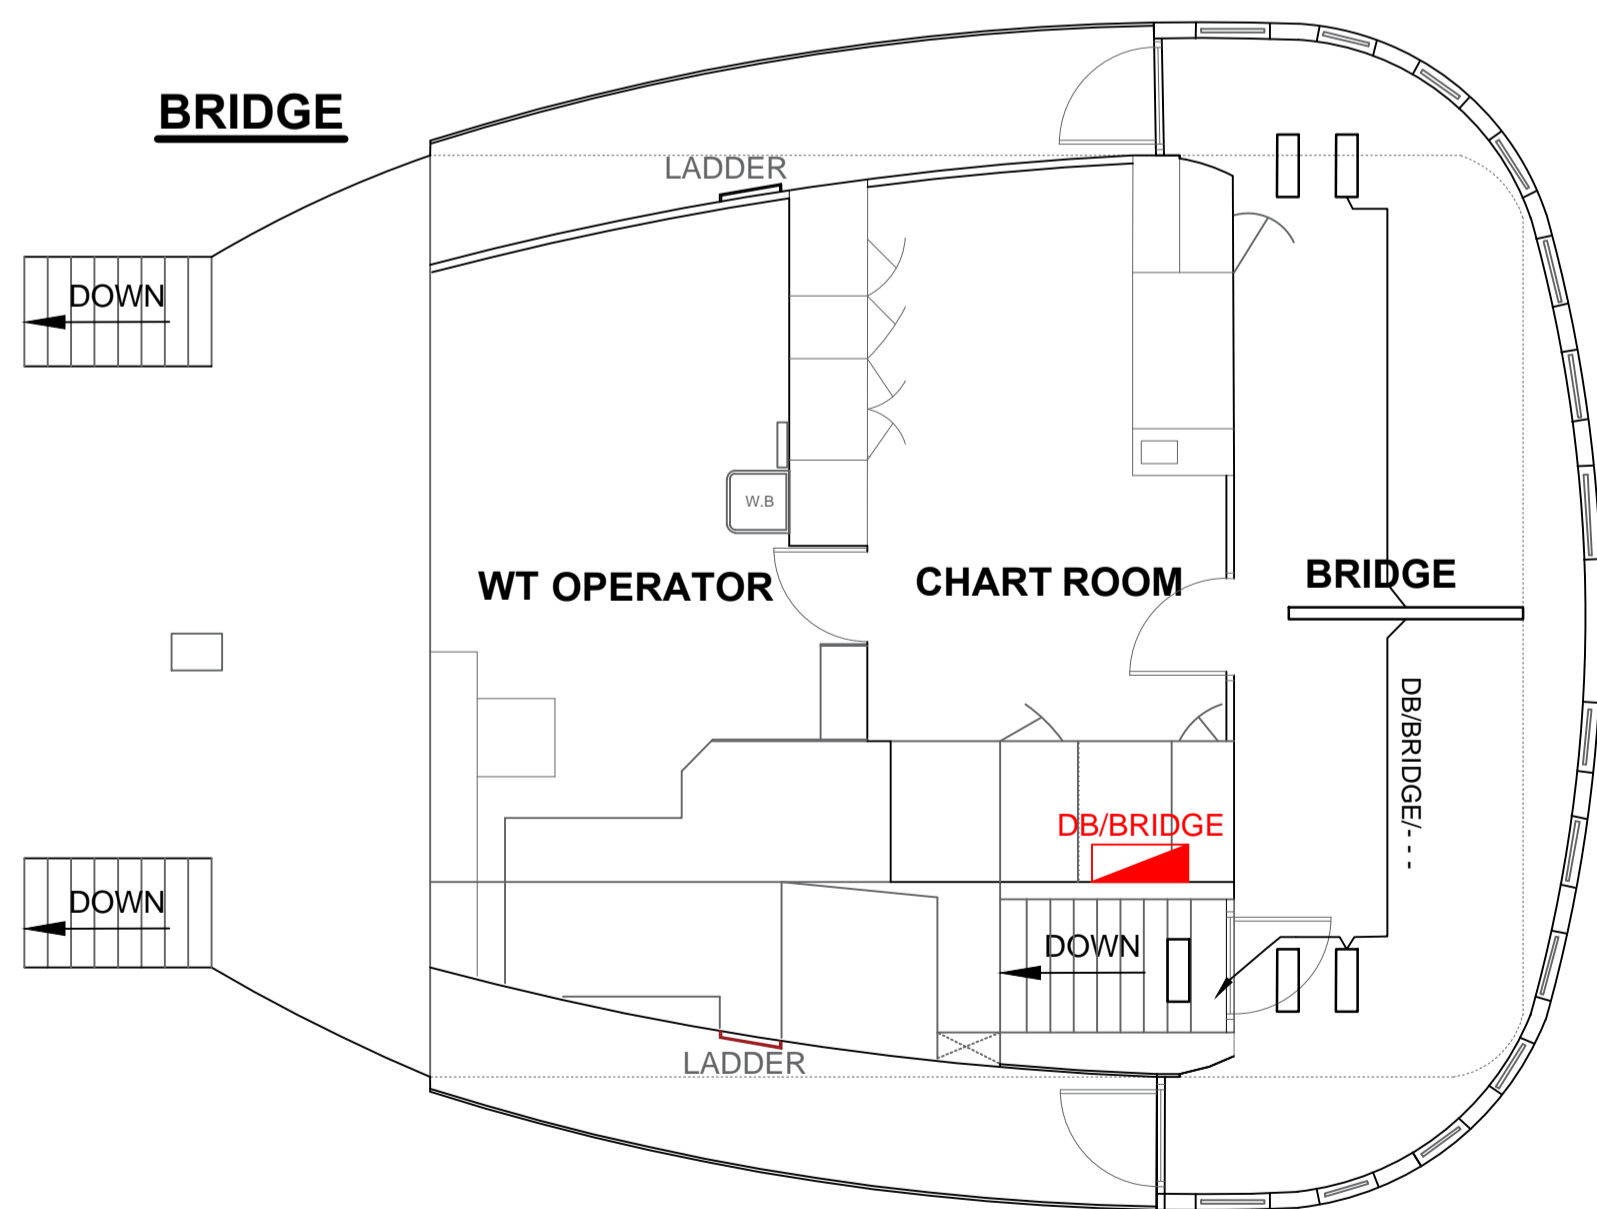

STUDIOS

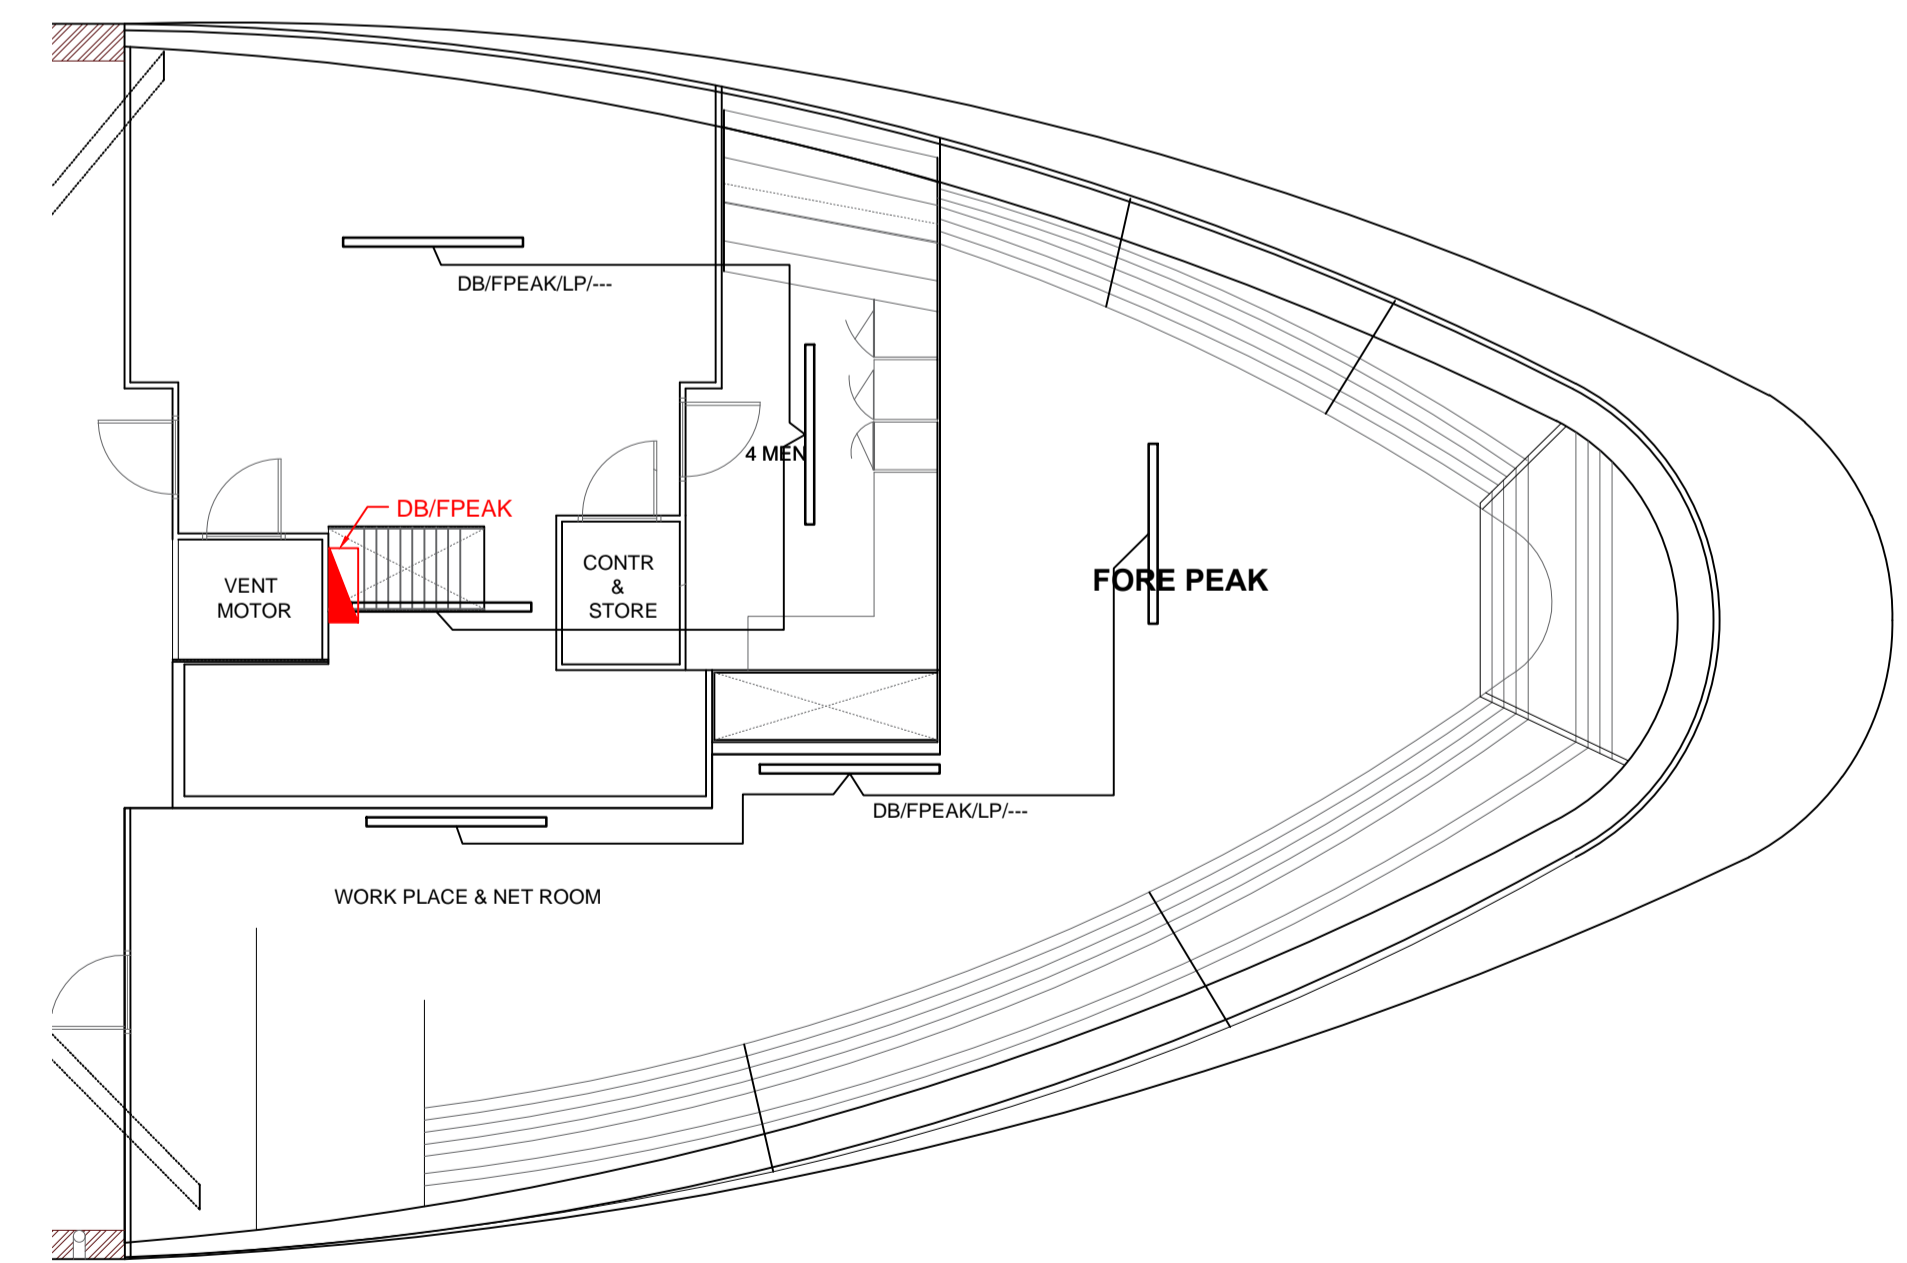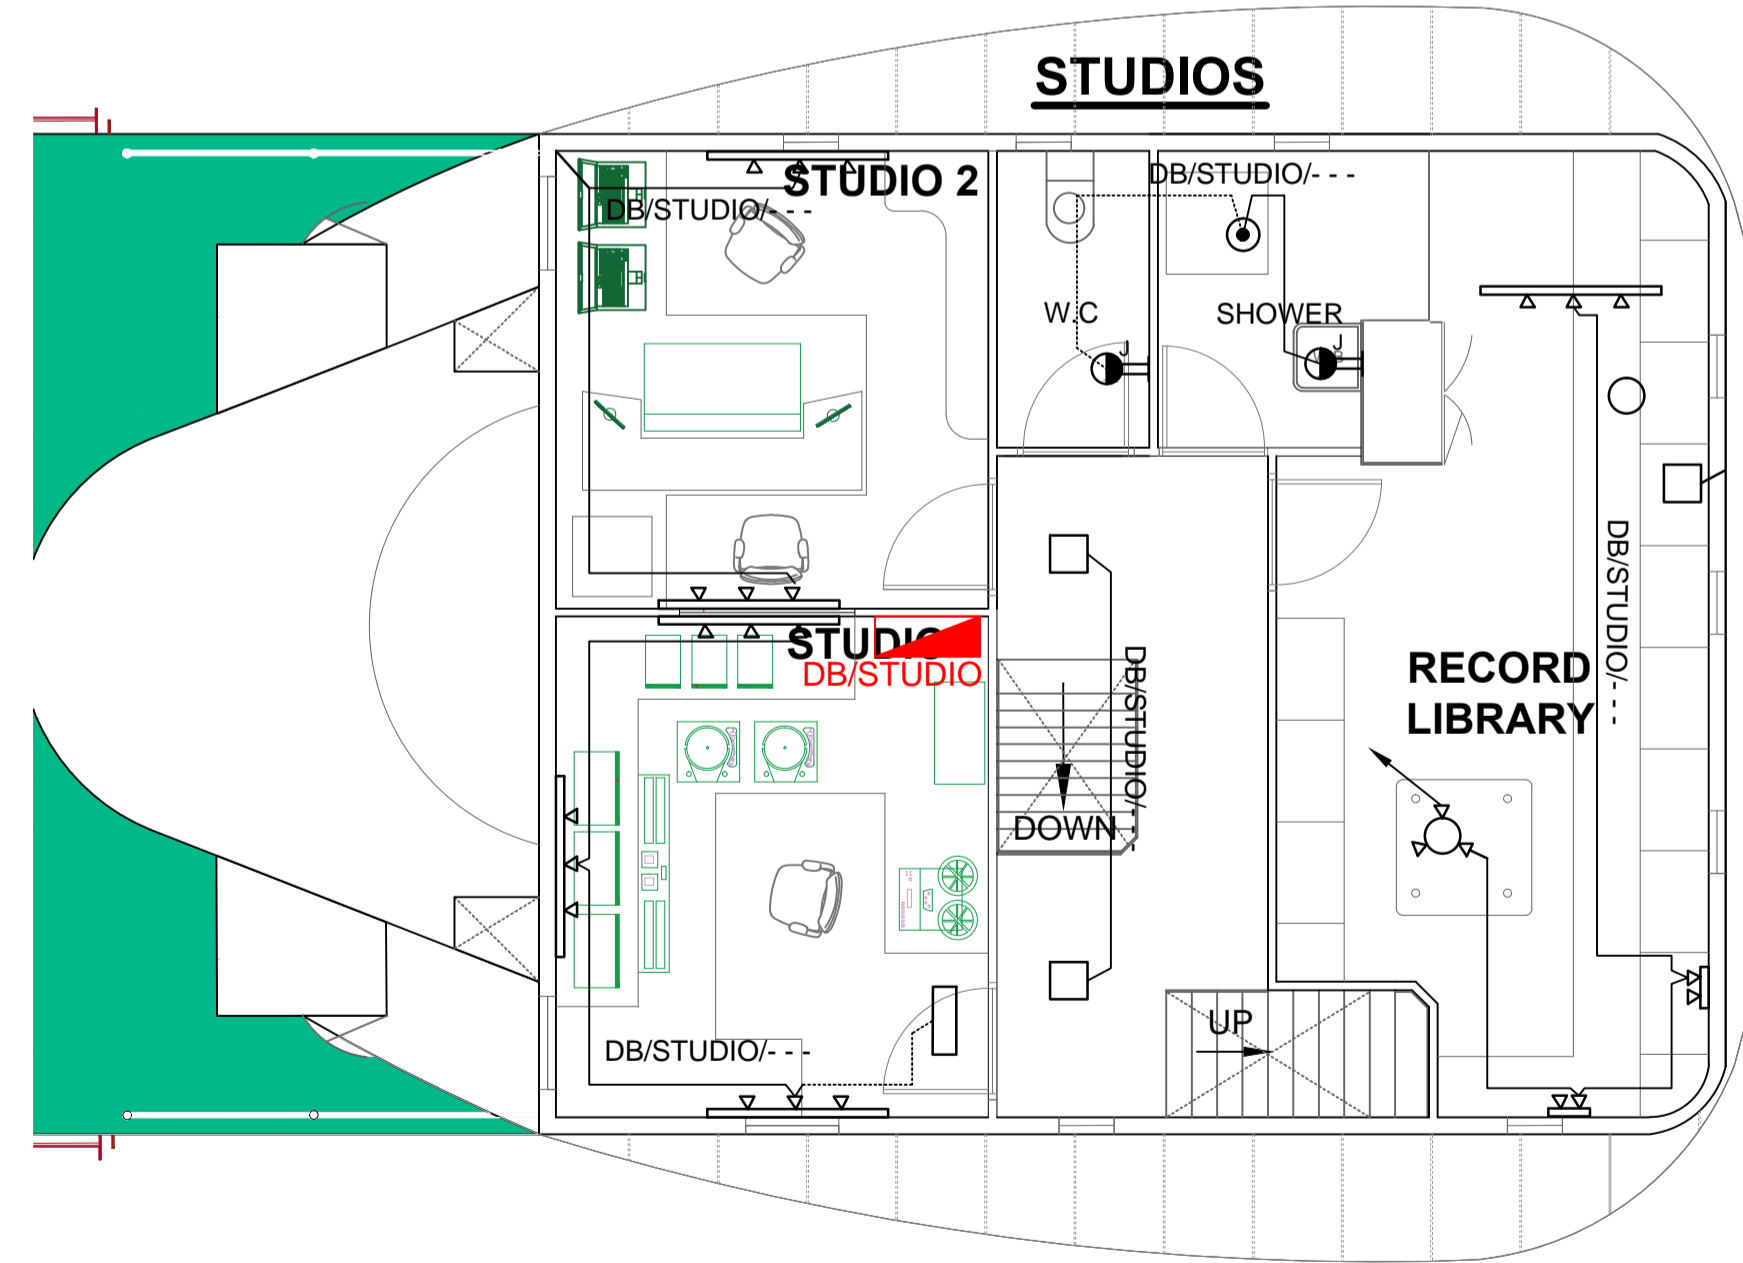

REV	DATE	BY	DESCRIPTION
RD	CJ		RECORD DRAWING

NOTES

Copyright Notice
 This drawing is subject to Copyright © Ross Revenge Plans (2015-2017) - Reg No 284707913 and may not be altered, reproduced or used other than for the purpose which it is issued.

Terms of Use
 Ross Revenge Plans utilise Digital Rights Management (DRM) on all products. Use of this file deems the recipient's acceptance of our DRM policies. Copy available on request.



ROSS REVENGE

DECK LIGHTING LAYOUTS

Date: APR.2016	Scale: 1:30
Drawn: CJ	Eng: GJ
Checked By:	Sheet Size: A1
File Ref:	
Drawing No: 558-RR-EL-001	
Status: RECORD DRAWING	